


PROPOSED PLAN

SCALE: 1/4" = 1'-0"

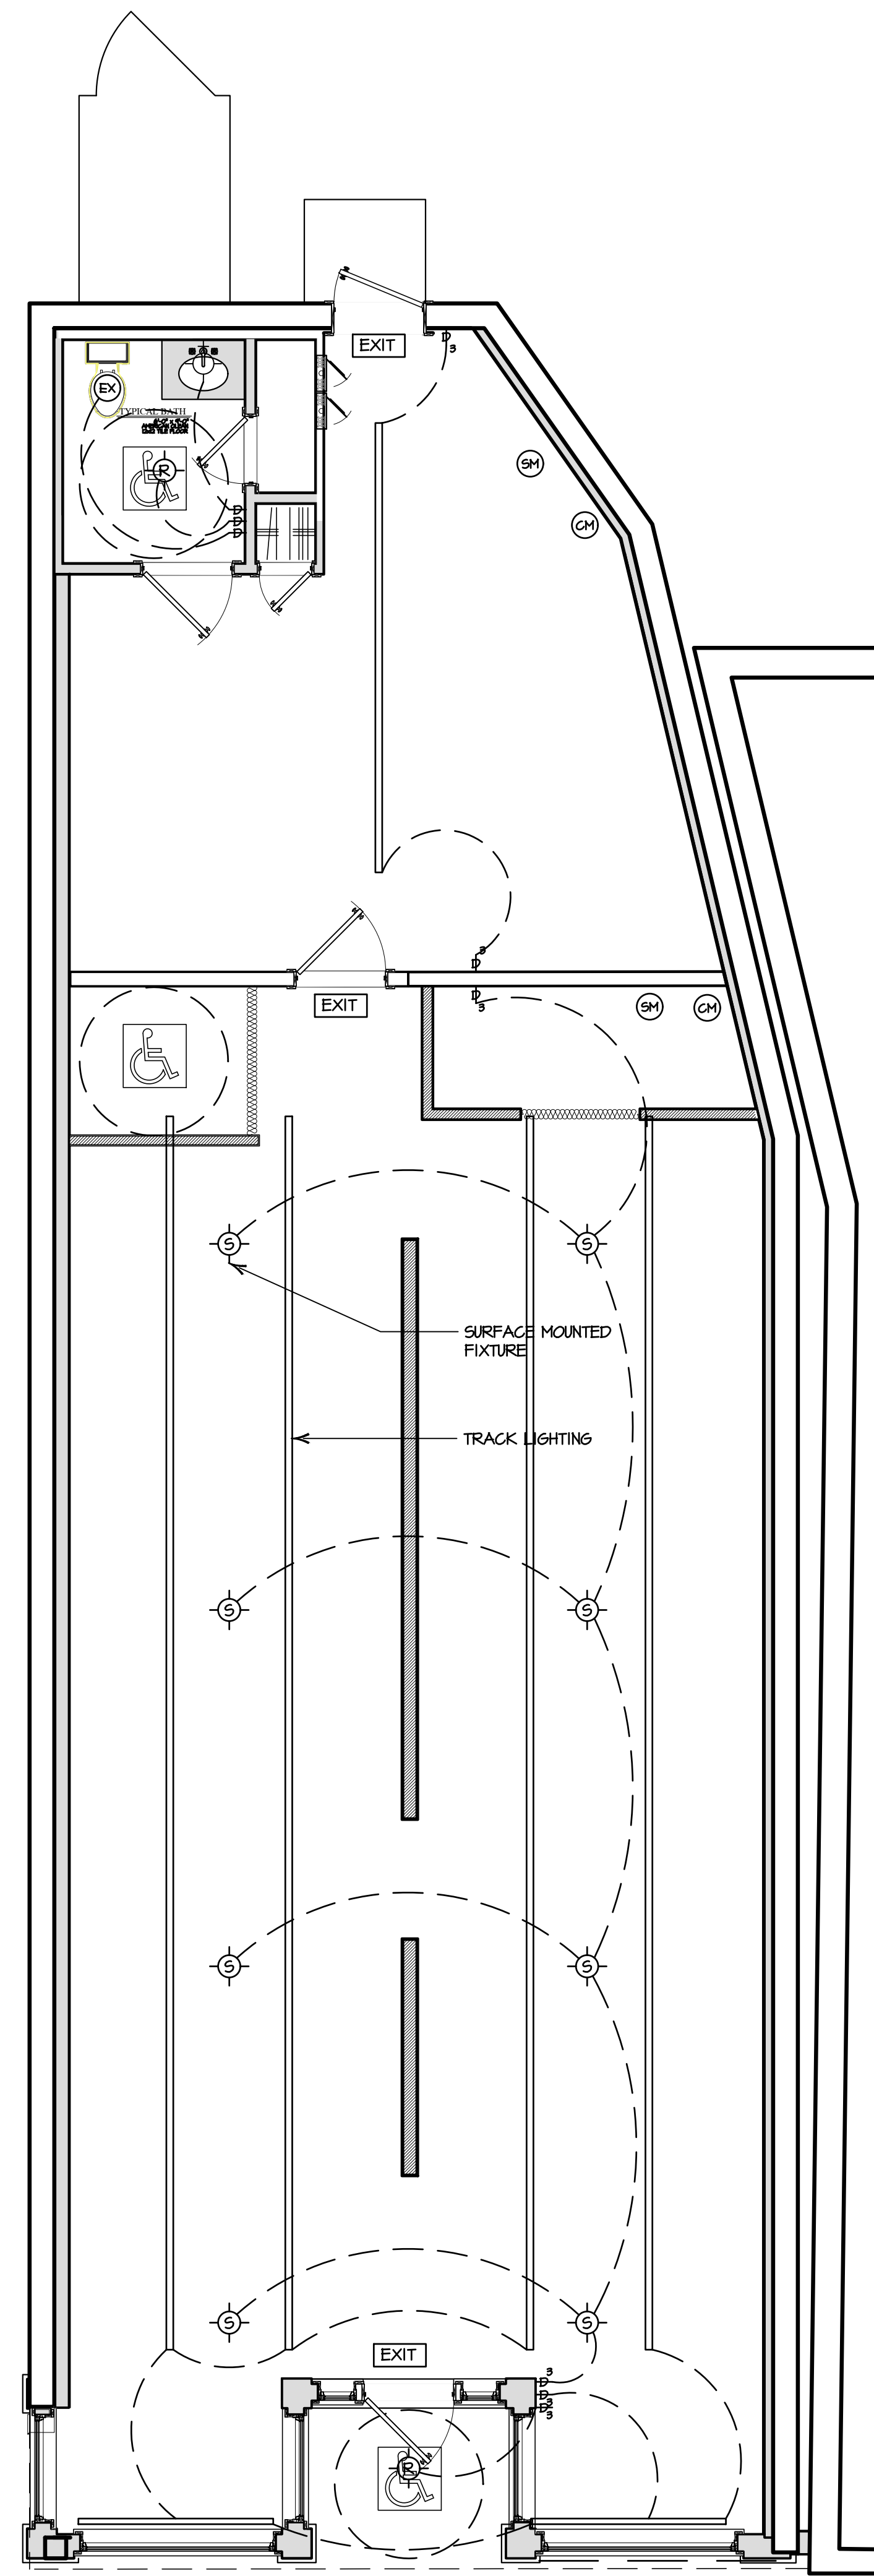

ELECTRICAL PLAN

SCALE: 1/4" = 1'-0"



PROPOSED FRONT ELEVATION

SCALE: 1/4" = 1'-0"

ELECTRICAL KEY			
Ⓢ	SWITCH	ⓈⓈ	DUPLEX REC. (GROUND FAULT INTERRUPT)
Ⓢ3	THREE-WAY SWITCH	ⓈⓈⓈ	DEDICATED OUTLET
Ⓢ4	FOUR-WAY SWITCH	ⓈⓈⓈⓈ	WEATHER PROOF OUTLET
ⓈD	DIMMER SWITCH	☎	TELEPHONE
ⓈWP	WEATHER PROOF SWITCH	☎	FAX JACK
ⓈⓈ	DUPLEX RECEPTACLE	Ⓢ	CABLE TELEVISION
ⓈⓈⓈ	QUADRUPLX RECEPTACLE	Ⓢ	DATA JACK
ⓈⓈⓈⓈ	DUPLEX REC. (1/2 HOT-1/2 ON SWITCH)	Ⓢ	SMOKE DETECTOR
ⓈⓈⓈⓈⓈ	DUPLEX REC. (GROUND FAULT INTERRUPT)	Ⓢ	CARBON MONOXIDE DETECTOR
		Ⓢ	SPEAKER
		Ⓢ	EXISTING SIGN WITH BATTERY BACKUP
		Ⓢ	EXHAUST FAN
		Ⓢ	THERMOSTAT
		Ⓢ	FLOOD LIGHT
		Ⓢ	CEILING FAN
		Ⓢ	CEILING FAN W/ LIGHT
		Ⓢ	FLORESCENT LIGHTING
		Ⓢ	SURFACE MOUNTED CEILING FIXTURE
		Ⓢ	SURFACE MOUNTED WALL FIXTURE
		Ⓢ	4" SQUARE RECESS LIGHT BY WAC
		Ⓢ	CHANDLIER
		Ⓢ	RECESS LIGHT - WALL WASH
		Ⓢ	PORCELAIN FIXTURE
		Ⓢ	TRACK LIGHTS
		Ⓢ	COVE LIGHTING
		Ⓢ	ART/WALL LIGHT

LF 57 MAIN ST. LLC
 57 Main Street
 Southampton, NY 11968

John P. Laffey A.I.A., P.C.
 828 Montauk Hwy.
 Water Mill, NY 11976
 PHONE (631) 726-5108 FAX (631) 726-5110

Scale: As Noted

Drawn By: B.A.

Checked By: J.P.L.

Date: SEP 18
 20 OCT 18
 15 JAN 19
 10 MAR 19
 05 MAY 19

A-01